
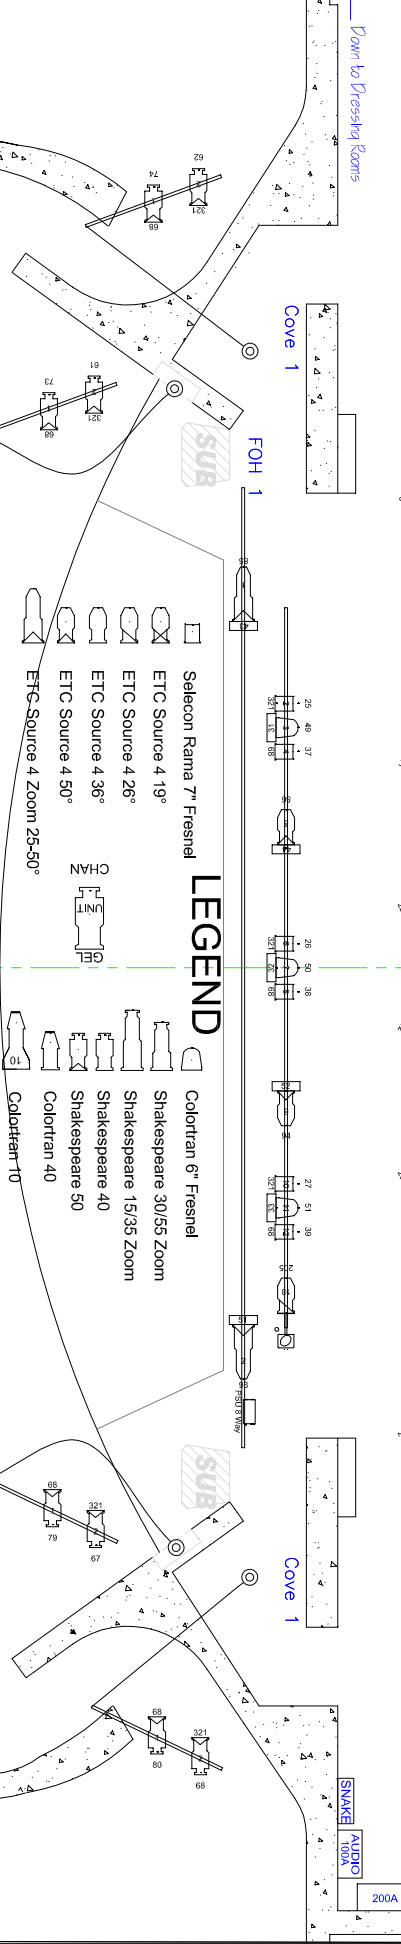


32 30 28 26 24 22 20 18 16 14 12 10 8 6 4 2 2 4 6 8 10 12 14 16 18 20 22 24 26 28 30 32

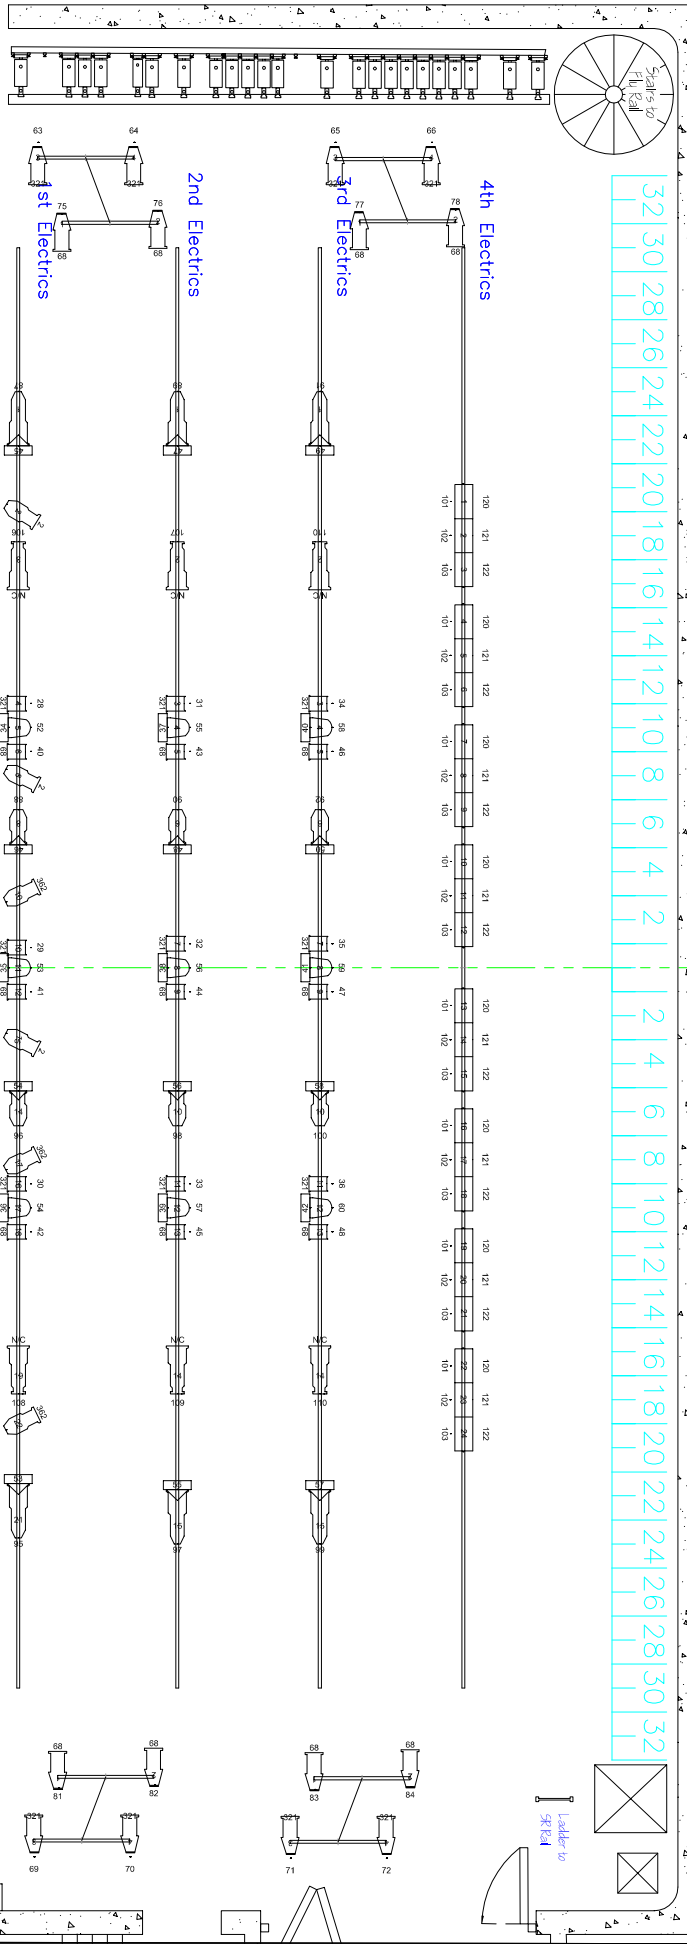

**NOTES:**

**SCALE: 1/8" = 1'-0"**

**DRAWING NO.: 8/9**

**SHOW: ARDEN STOCK**

**DRAWN BY: ANDREW TUDGE**

**STAGE LIGHTING PLAN**

**DATE: 01/03/2011 11:00 PM**

**ARDEN**